




ELEVATION A
SCALE 1:50

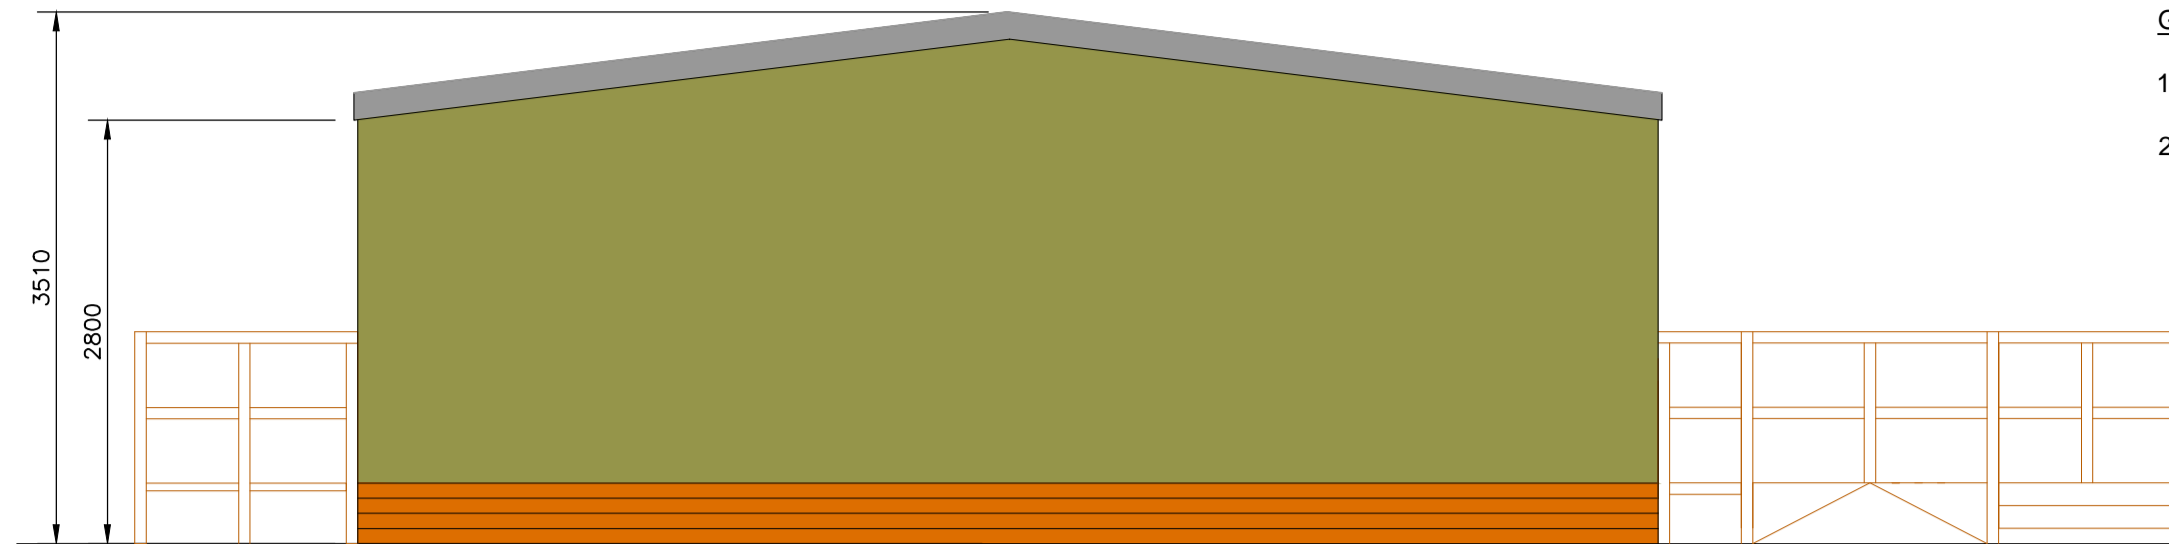

ELEVATION B
SCALE 1:50

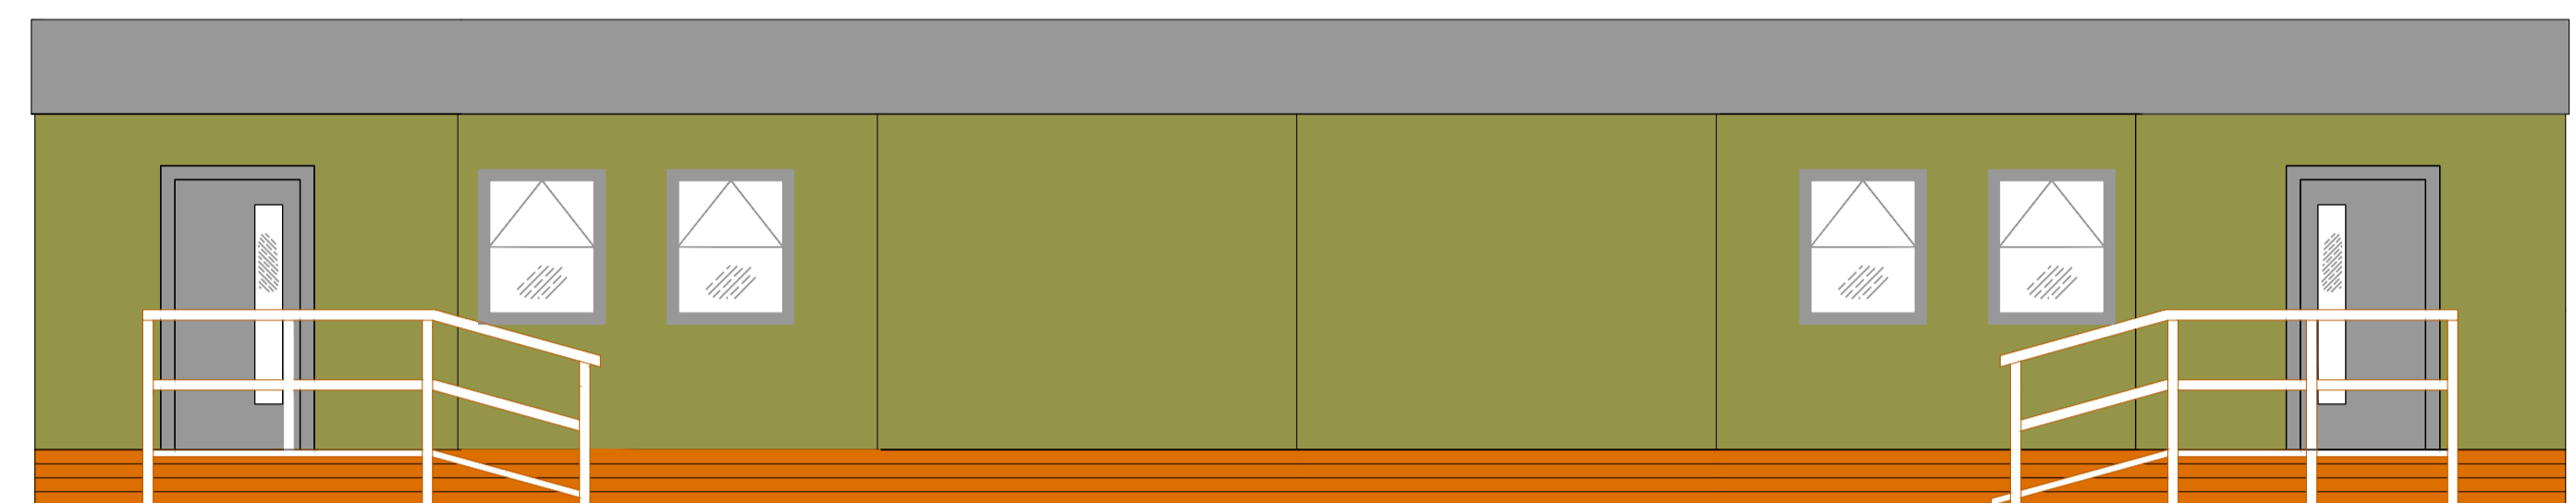

ELEVATION C
SCALE 1:50

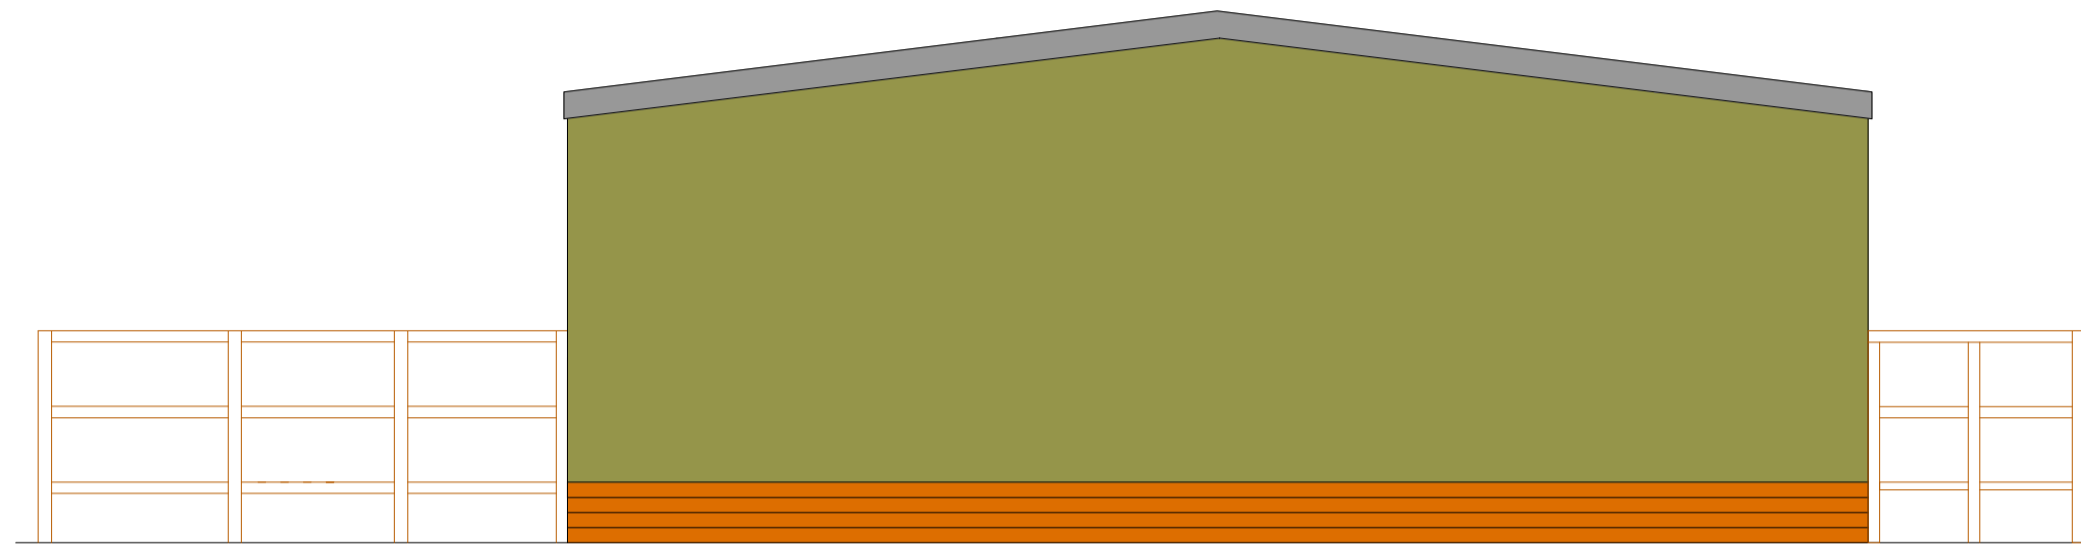


ELEVATION D
SCALE 1:50

GENERAL NOTES
1. Do not scale.
2. All dimensions are in millimetres unless otherwise specified.

- KEY**
- Distribution board
 - 28w 2D bulkhead light
 - 28w 2D Emergency bulkhead light
 - 1600 HF TS fluorescent strip light
 - 1600 TS Dimming Lamp
 - 8w Emergency maintained light (250mm from ceiling)
 - 8w Emergency non maintained light (250mm from ceiling)
 - Double socket (540mm AFFL)
 - 20amp double pole switch (540mm AFFL)
 - Grid switch (1104mm AFFL)
 - Pull switch
 - 50L multipoint water heater
 - Time Clock (350mm from ceiling)
 - Fan
 - Fan Isolator (250mm from ceiling)
 - Frost Guard (400mm from ceiling)

- ROOM TYPE COLOUR CODING**
- Classroom Area
 - Store Area
 - Corridor and Lobby Area
 - Ablutions Area

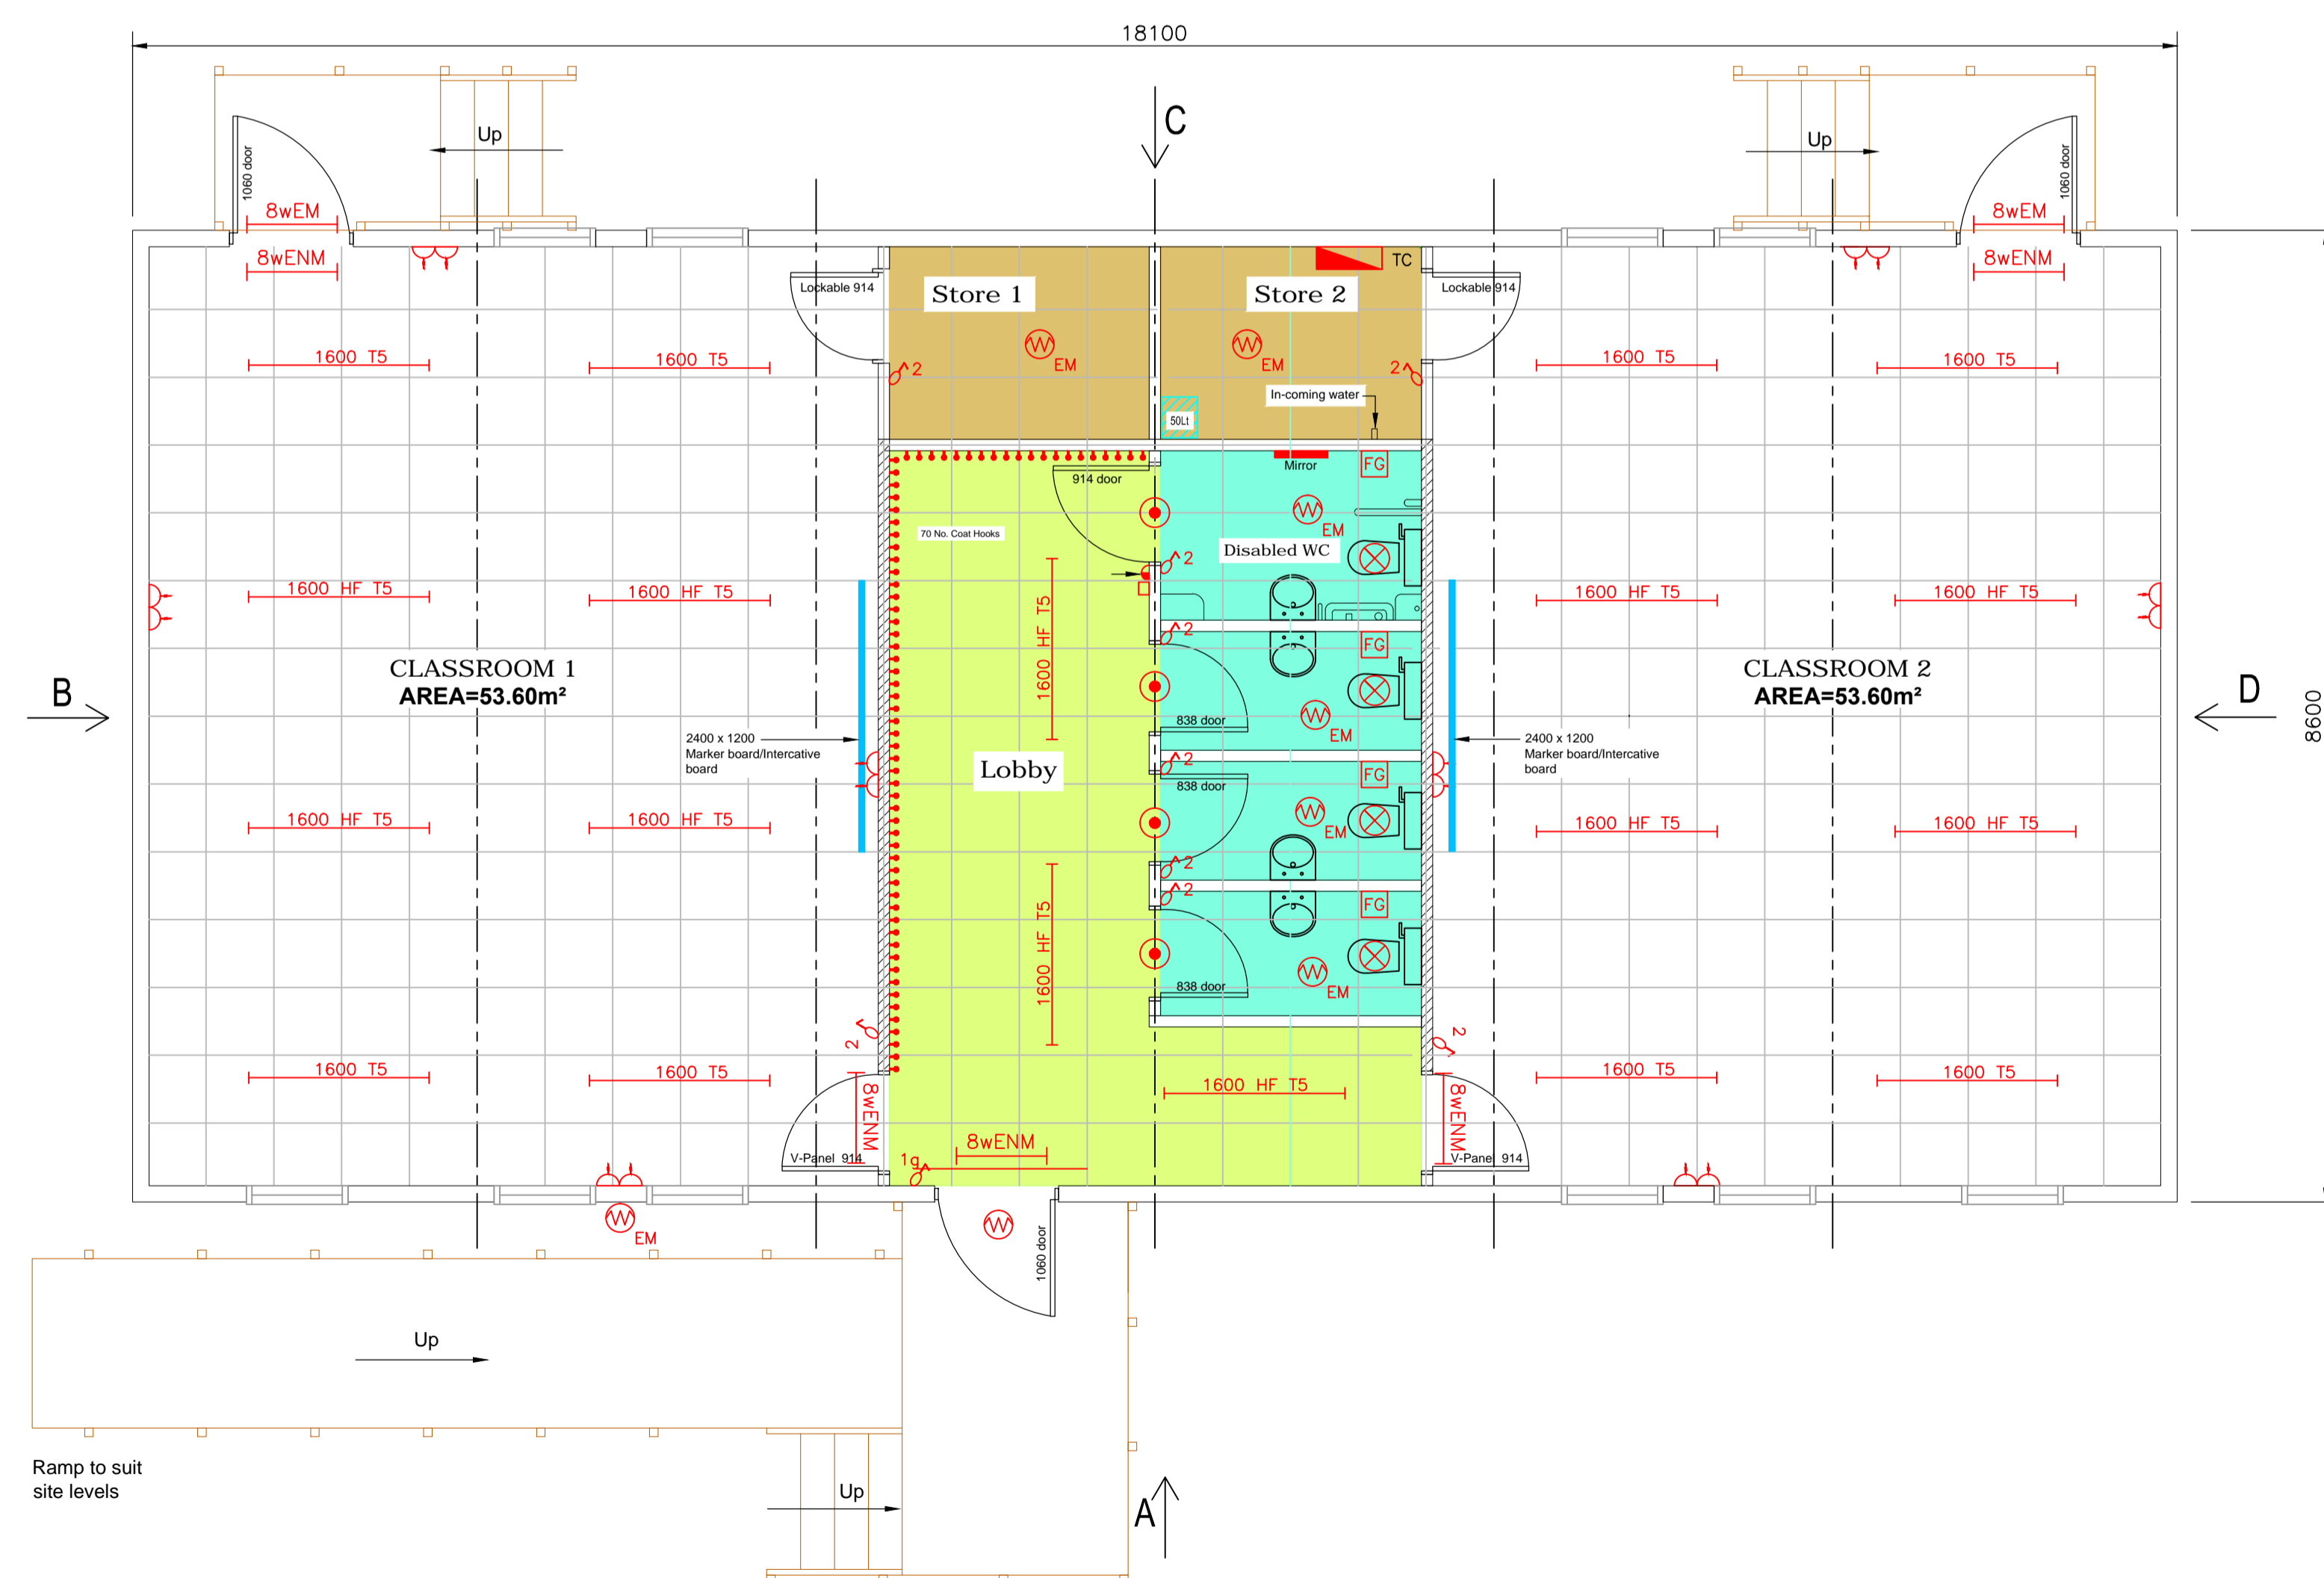

FLOOR PLAN AND ELEVATIONS DRAWING
SCALE 1:50



EXAMPLE PHOTOGRAPH - EXTERNAL



EXAMPLE PHOTOGRAPH - INTERNAL

NO.	REVISIONS	CHK.	DATE

MRC
MARTIN REYNOLDS CONSTRUCTION

BARROWHAY DROVE
DOWNHAM MARKET
NORFOLK PE38 0AL
TEL: 01936 324297
FAX: 01936 324432
EMAIL: sales@mrcmrcconstruction.co.uk
www.mrcmrcconstruction.co.uk

CLIENT
EXAMPLE DRAWING

SITE DETAILS
6 BAY DOUBLE CLASSROOM
WITH DISABLED TOILET

FILE NUMBER	DRAWING No.	REVISION
Scale: 1:50 @ A1		
DRAWN DTW	DATE 13/10/2009	

COPYRIGHT OF MRC CONSTRUCTION & MUST NOT BE COPIED OR REPRODUCED WITHOUT THEIR WRITTEN CONSENT